


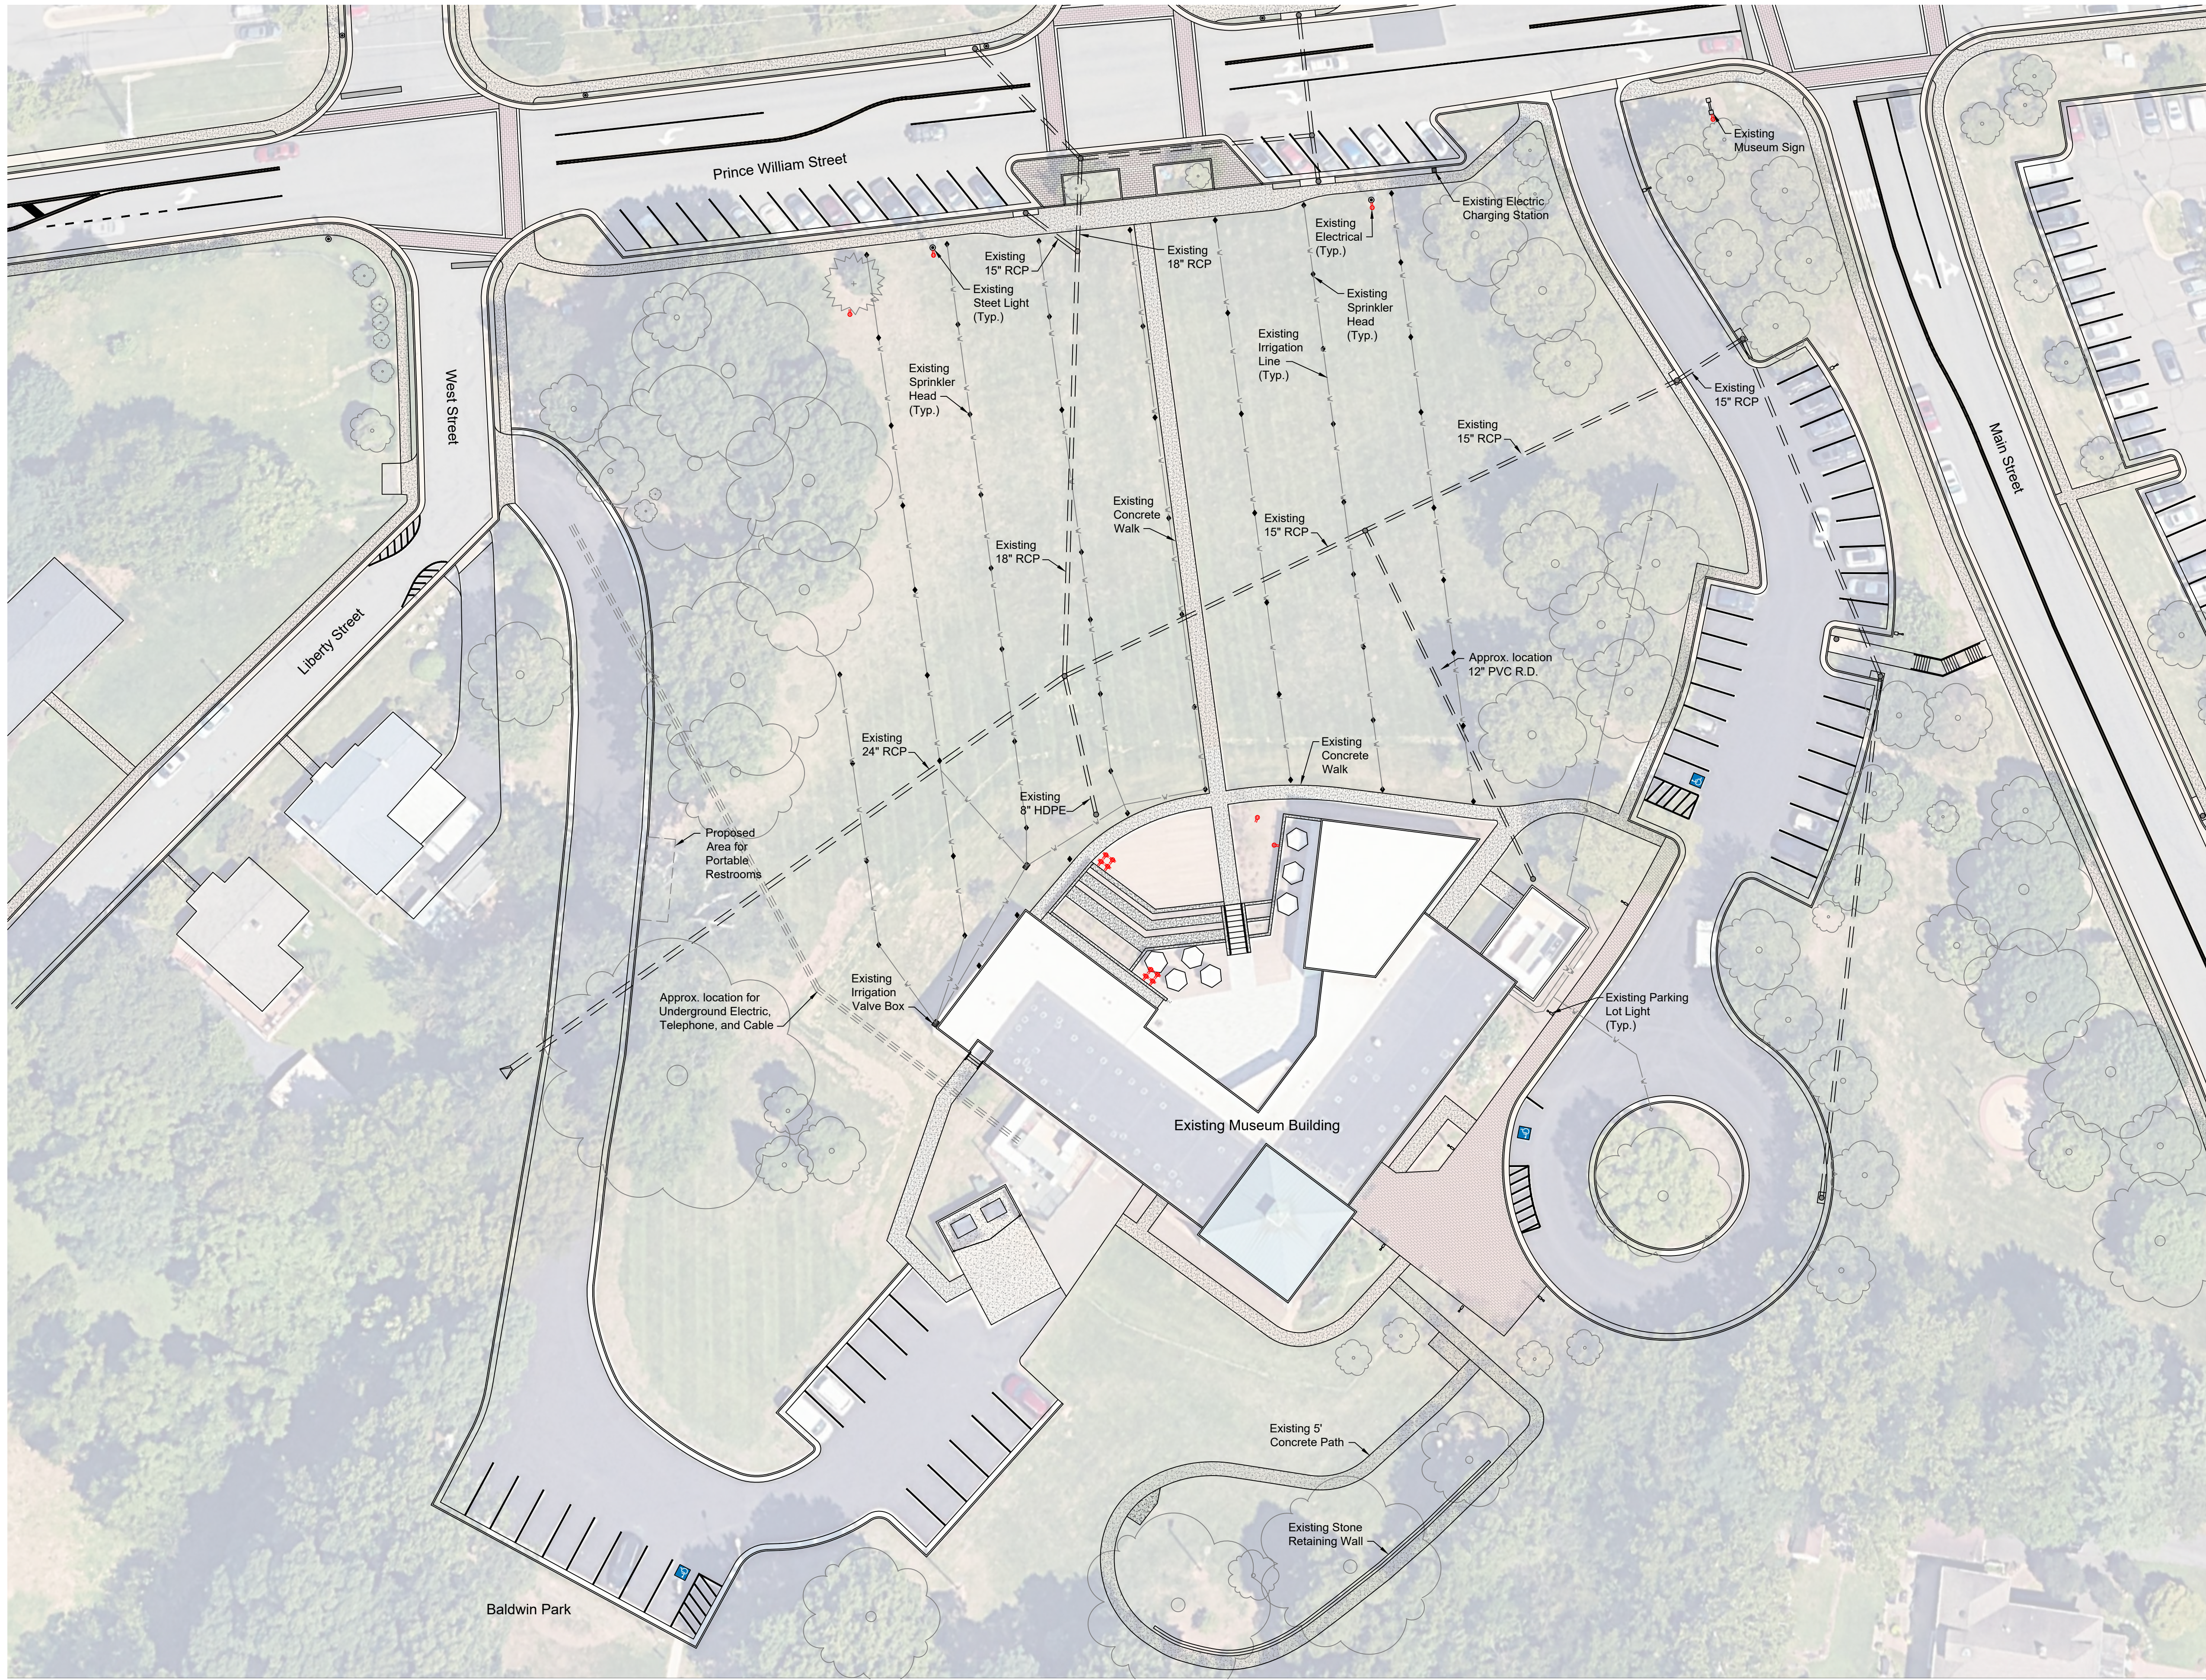

- Legend**
- Existing Electrical Outlet
 - Existing Sprinkler Head
 - Existing Irrigation Valve Box
 - Existing Irrigation/Water Line
 - Existing Museum Sign
 - Existing Electrical Charging Station
 - Existing Street Light
 - Existing Parking Lot Light

SCALE
0 30 60 Ft.
1" = 30' Horiz.

CITY OF MANASSAS MUSEUM

SITE PLAN

SHEET
1 of 1
SCALE: 1" = 30'

CITY OF MANASSAS, VIRGINIA
DEPARTMENT OF ENGINEERING
9027 CENTER STREET
MANASSAS, VIRGINIA 20110

REVISIONS	
DATE	DESCRIPTION

MANASSAS PROJECT NO:	10/30/24
DATE OF PLAN ISSUANCE:	N/A
CONSULTANT PROJECT ID:	10/30/24
DESIGNED BY:	BTP DATE: 10/30/24
DRAWN BY:	BTP DATE: 10/30/24
CHECKED BY:	DATE:
APPROVED BY:	DATE:

